





1 FIRST FLOOR PLAN
SCALE 1:250

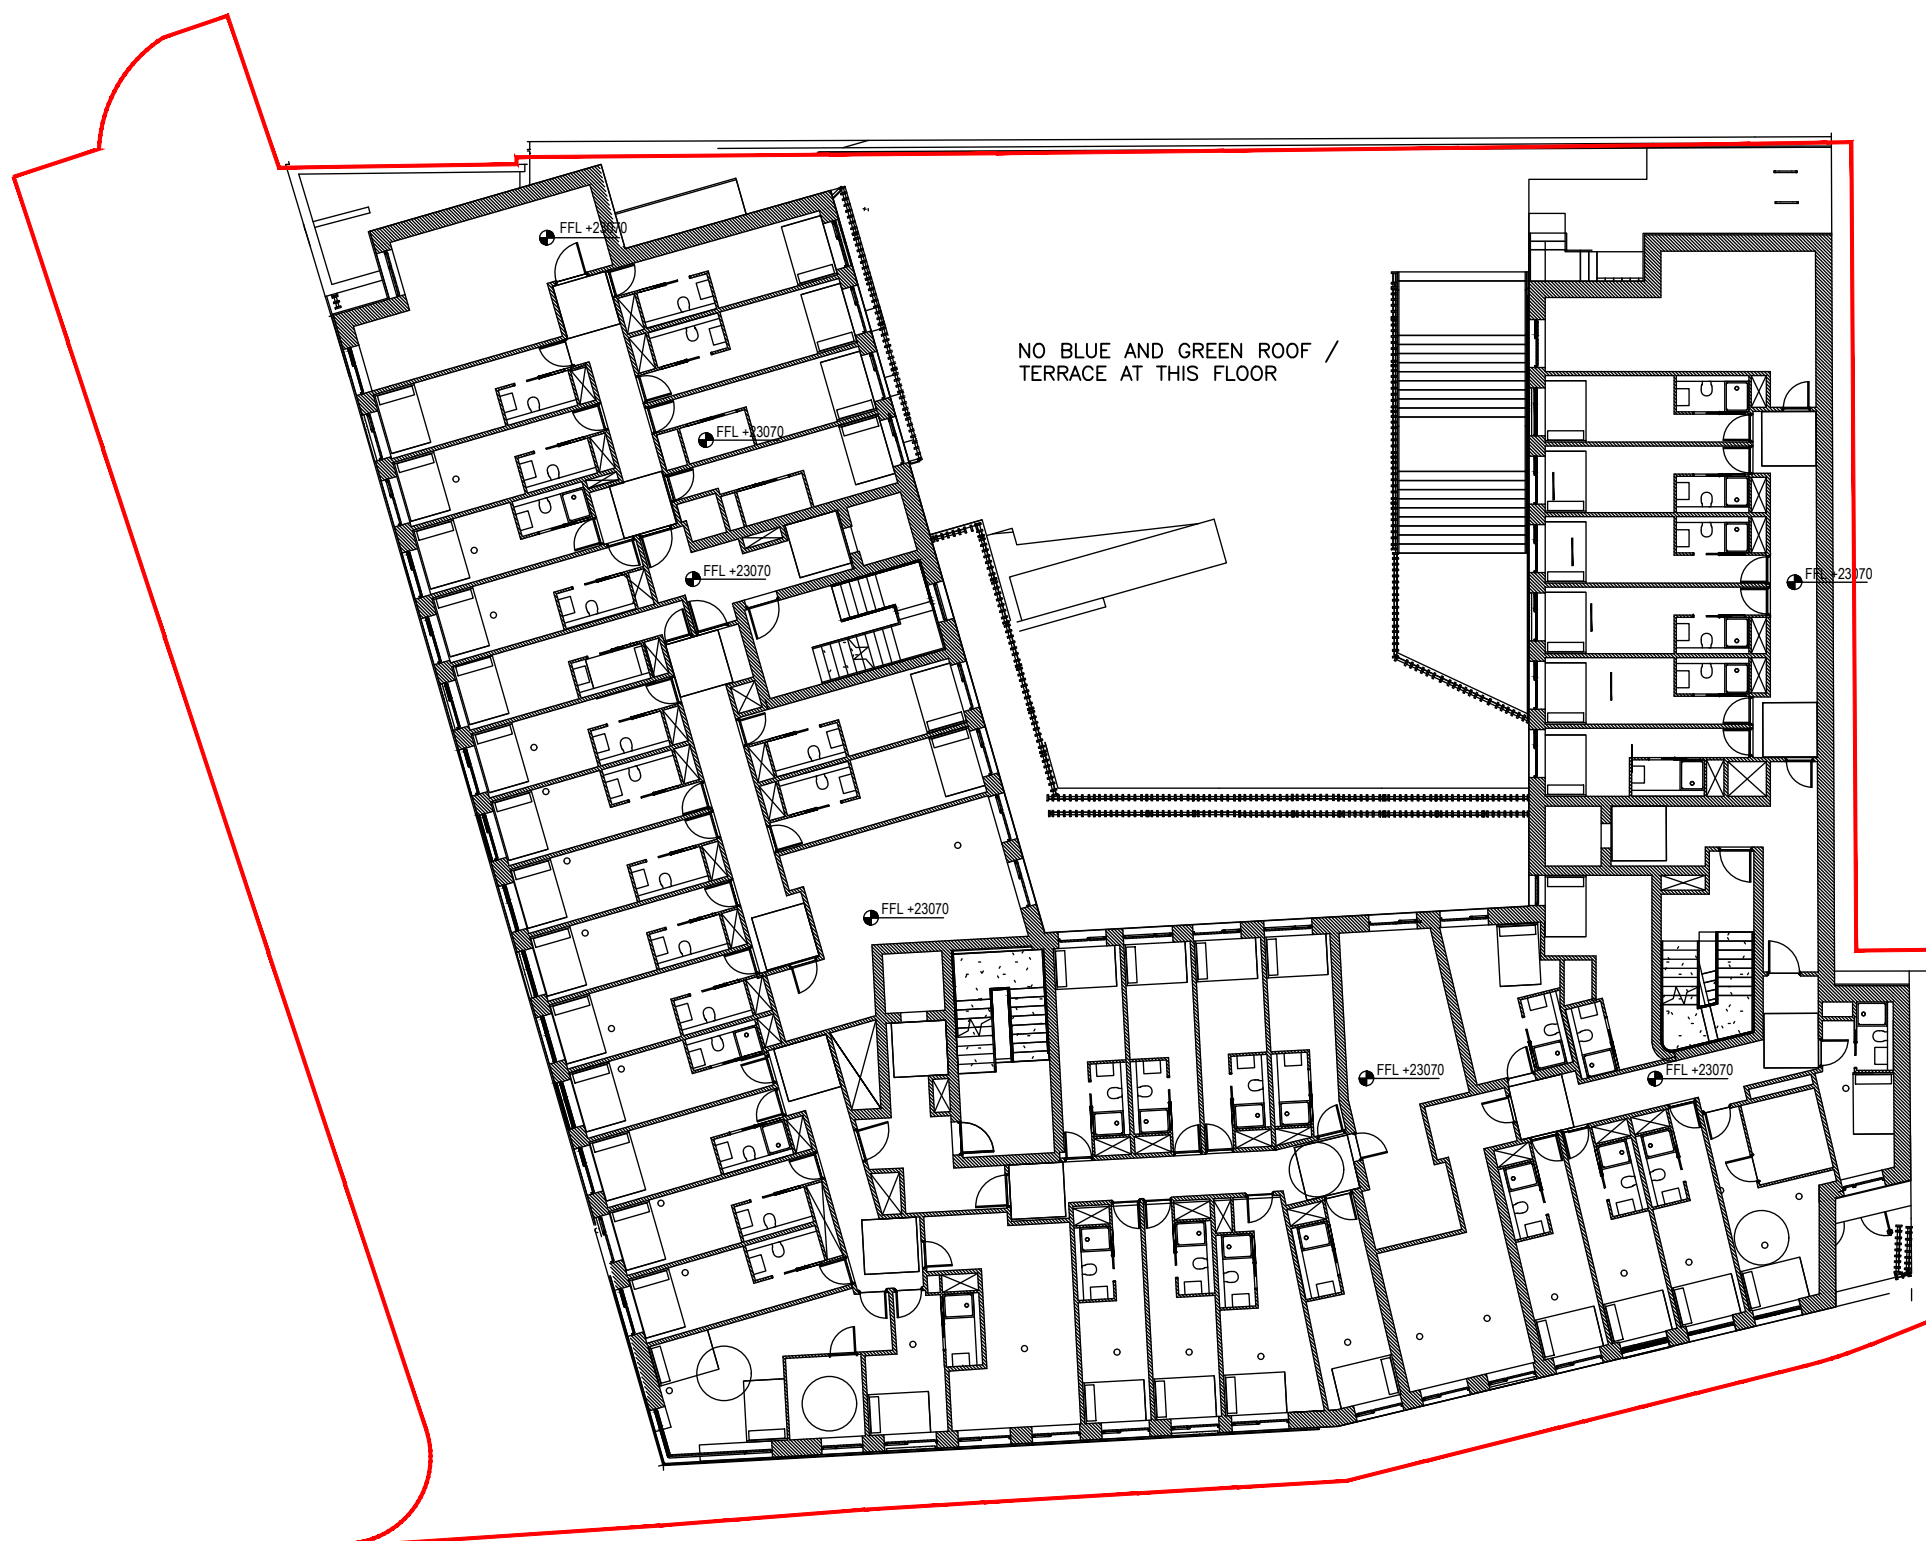

2 SECOND FLOOR PLAN
SCALE 1:250



3 THIRD FLOOR PLAN
SCALE 1:250

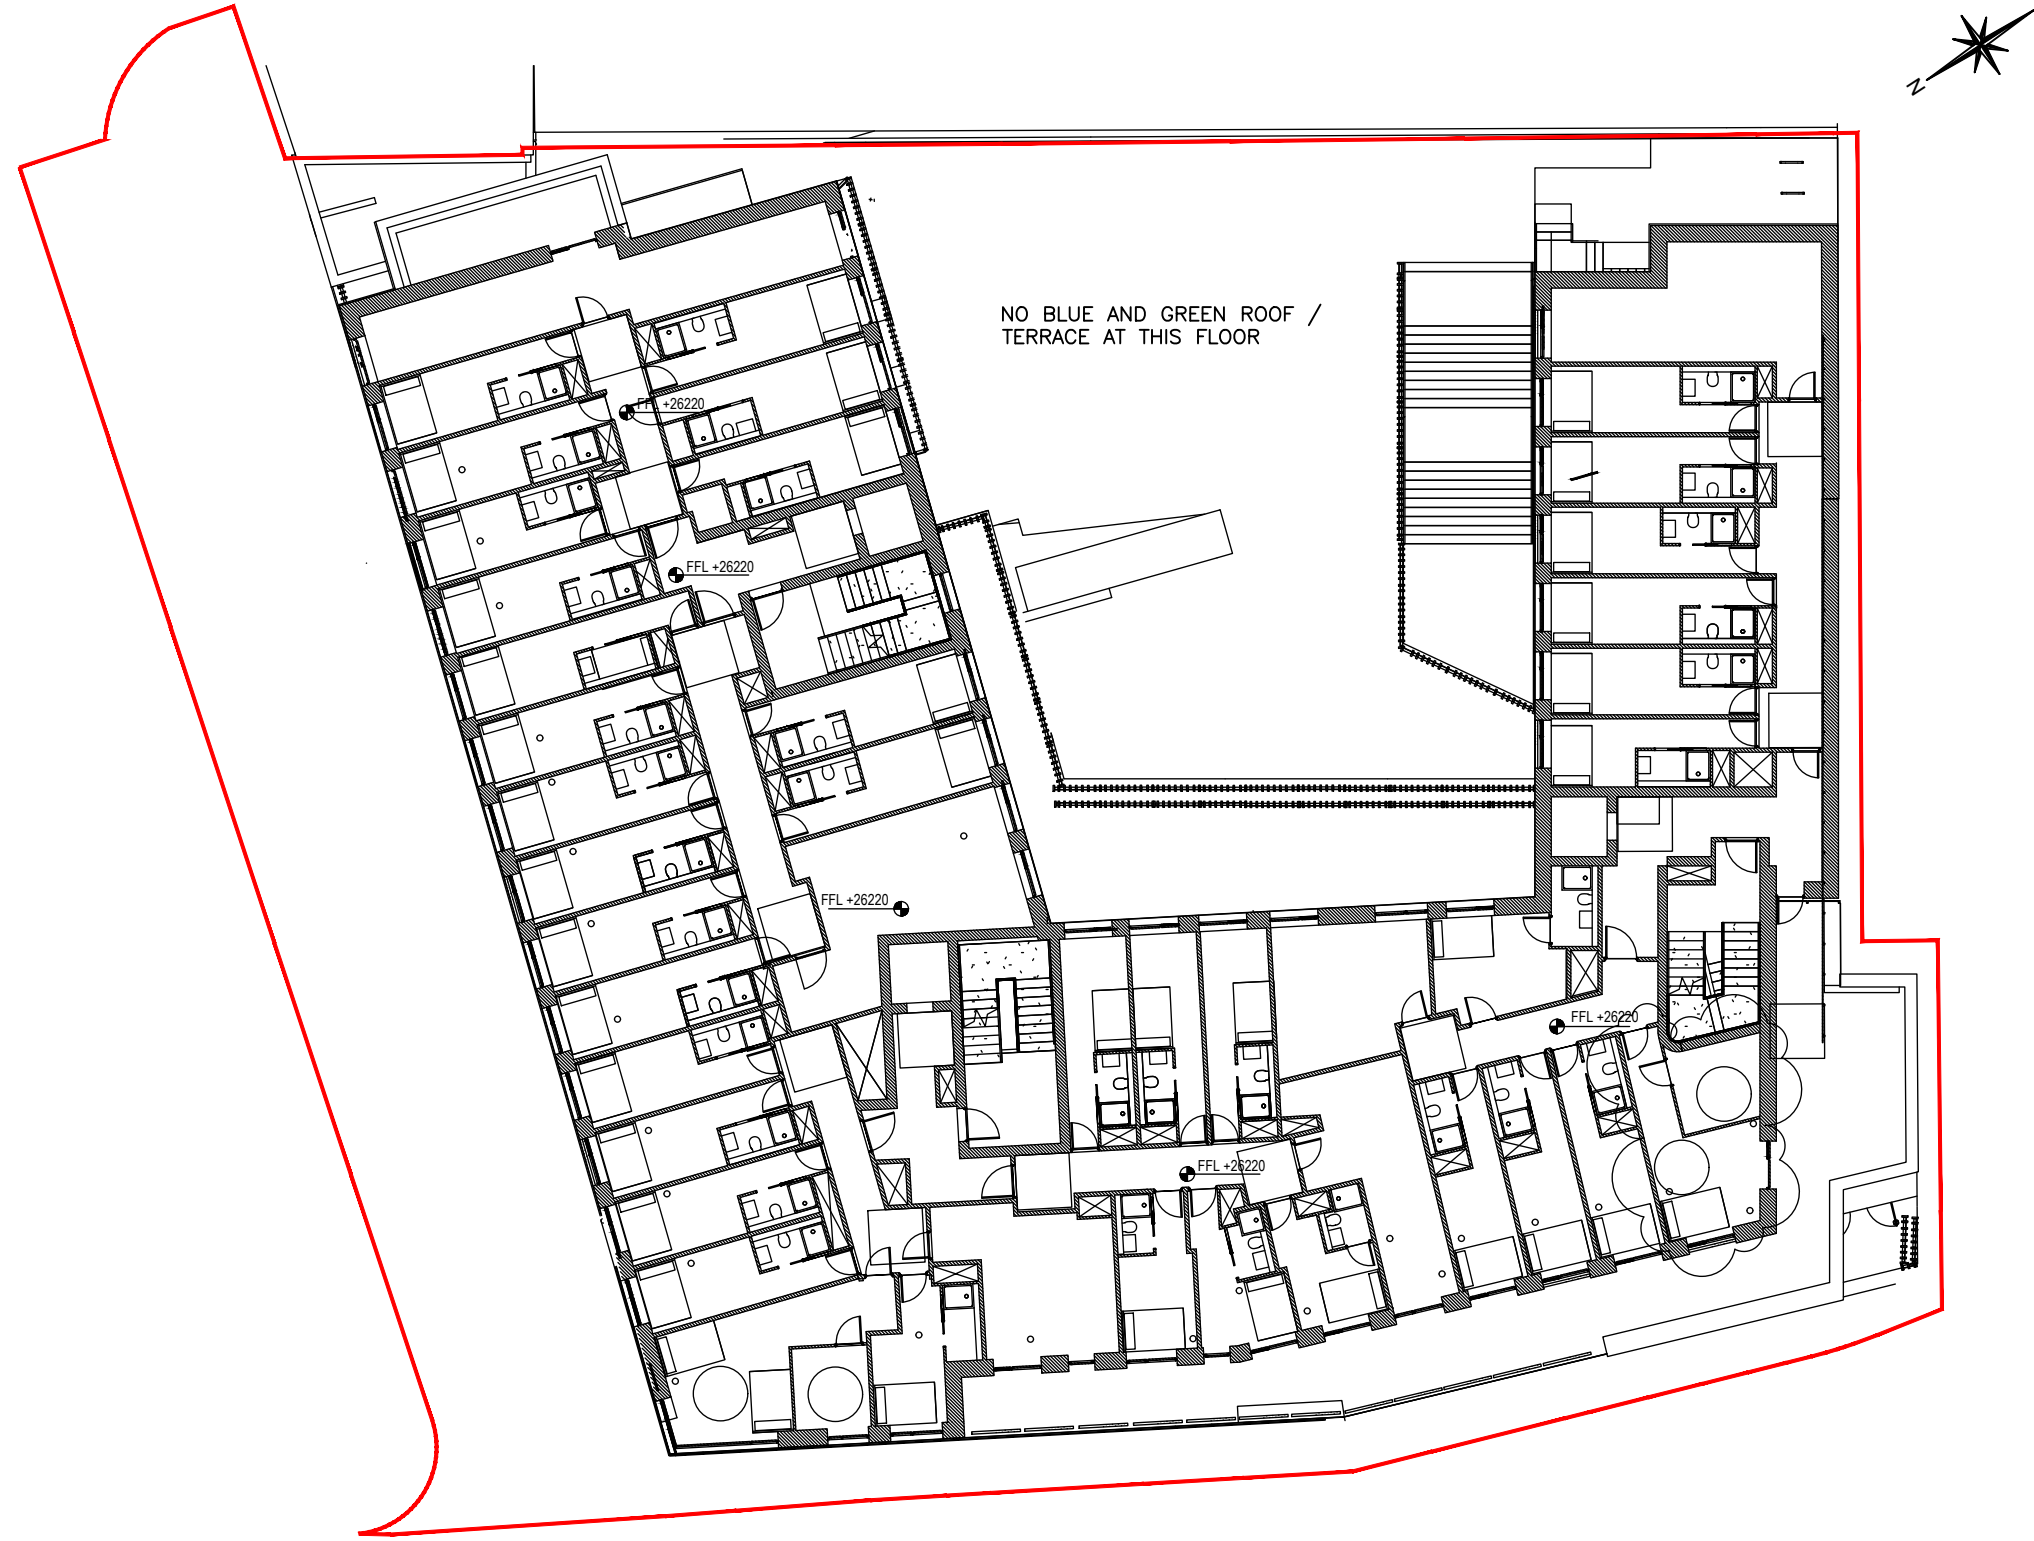

4 FOURTH FLOOR PLAN
SCALE 1:250

P03	ISSUED FOR STAGE 3 LRD PLANNING	POS	13.05.25
P02	ISSUED FOR STAGE 3 LRD PLANNING	POS	06.05.25
P01	ISSUED FOR STAGE 2 LRD PLANNING	POS	06.12.24
Rev	Revision details		By Date

Drawn by:	POS	For discussion	
Design by:	MW	For tender	
Check by:	AS	For construction	



JJ Campbell & Associates
Consulting Civil & Structural Engineers
+353 (0) 209 05158
info@jca.ie
F1 Nalgrove Office Park,
Ballymore, Dublin 14, Ireland,
D14A6P5.
www.jca.ie



-IQNet-
INTERNATIONAL CERTIFICATION NETWORK



MEMBER OF ACEI

Client
ARBATAX ULC - BLACKPITS

Architect
HORAN RAINFORD ARCHITECTS

Project Name
**BLACKPITTS -
STUDENT ACCOMADATION**

Drawing Title
**1st FLOOR 2nd FLOOR
3rd FLOOR 4th FLOOR**

Original Drawing Size : A1
Scale : SEE DRAWING
Copyright © JJ Campbell & Assoc

Project No.
2419-10

Drawing No.
C4